


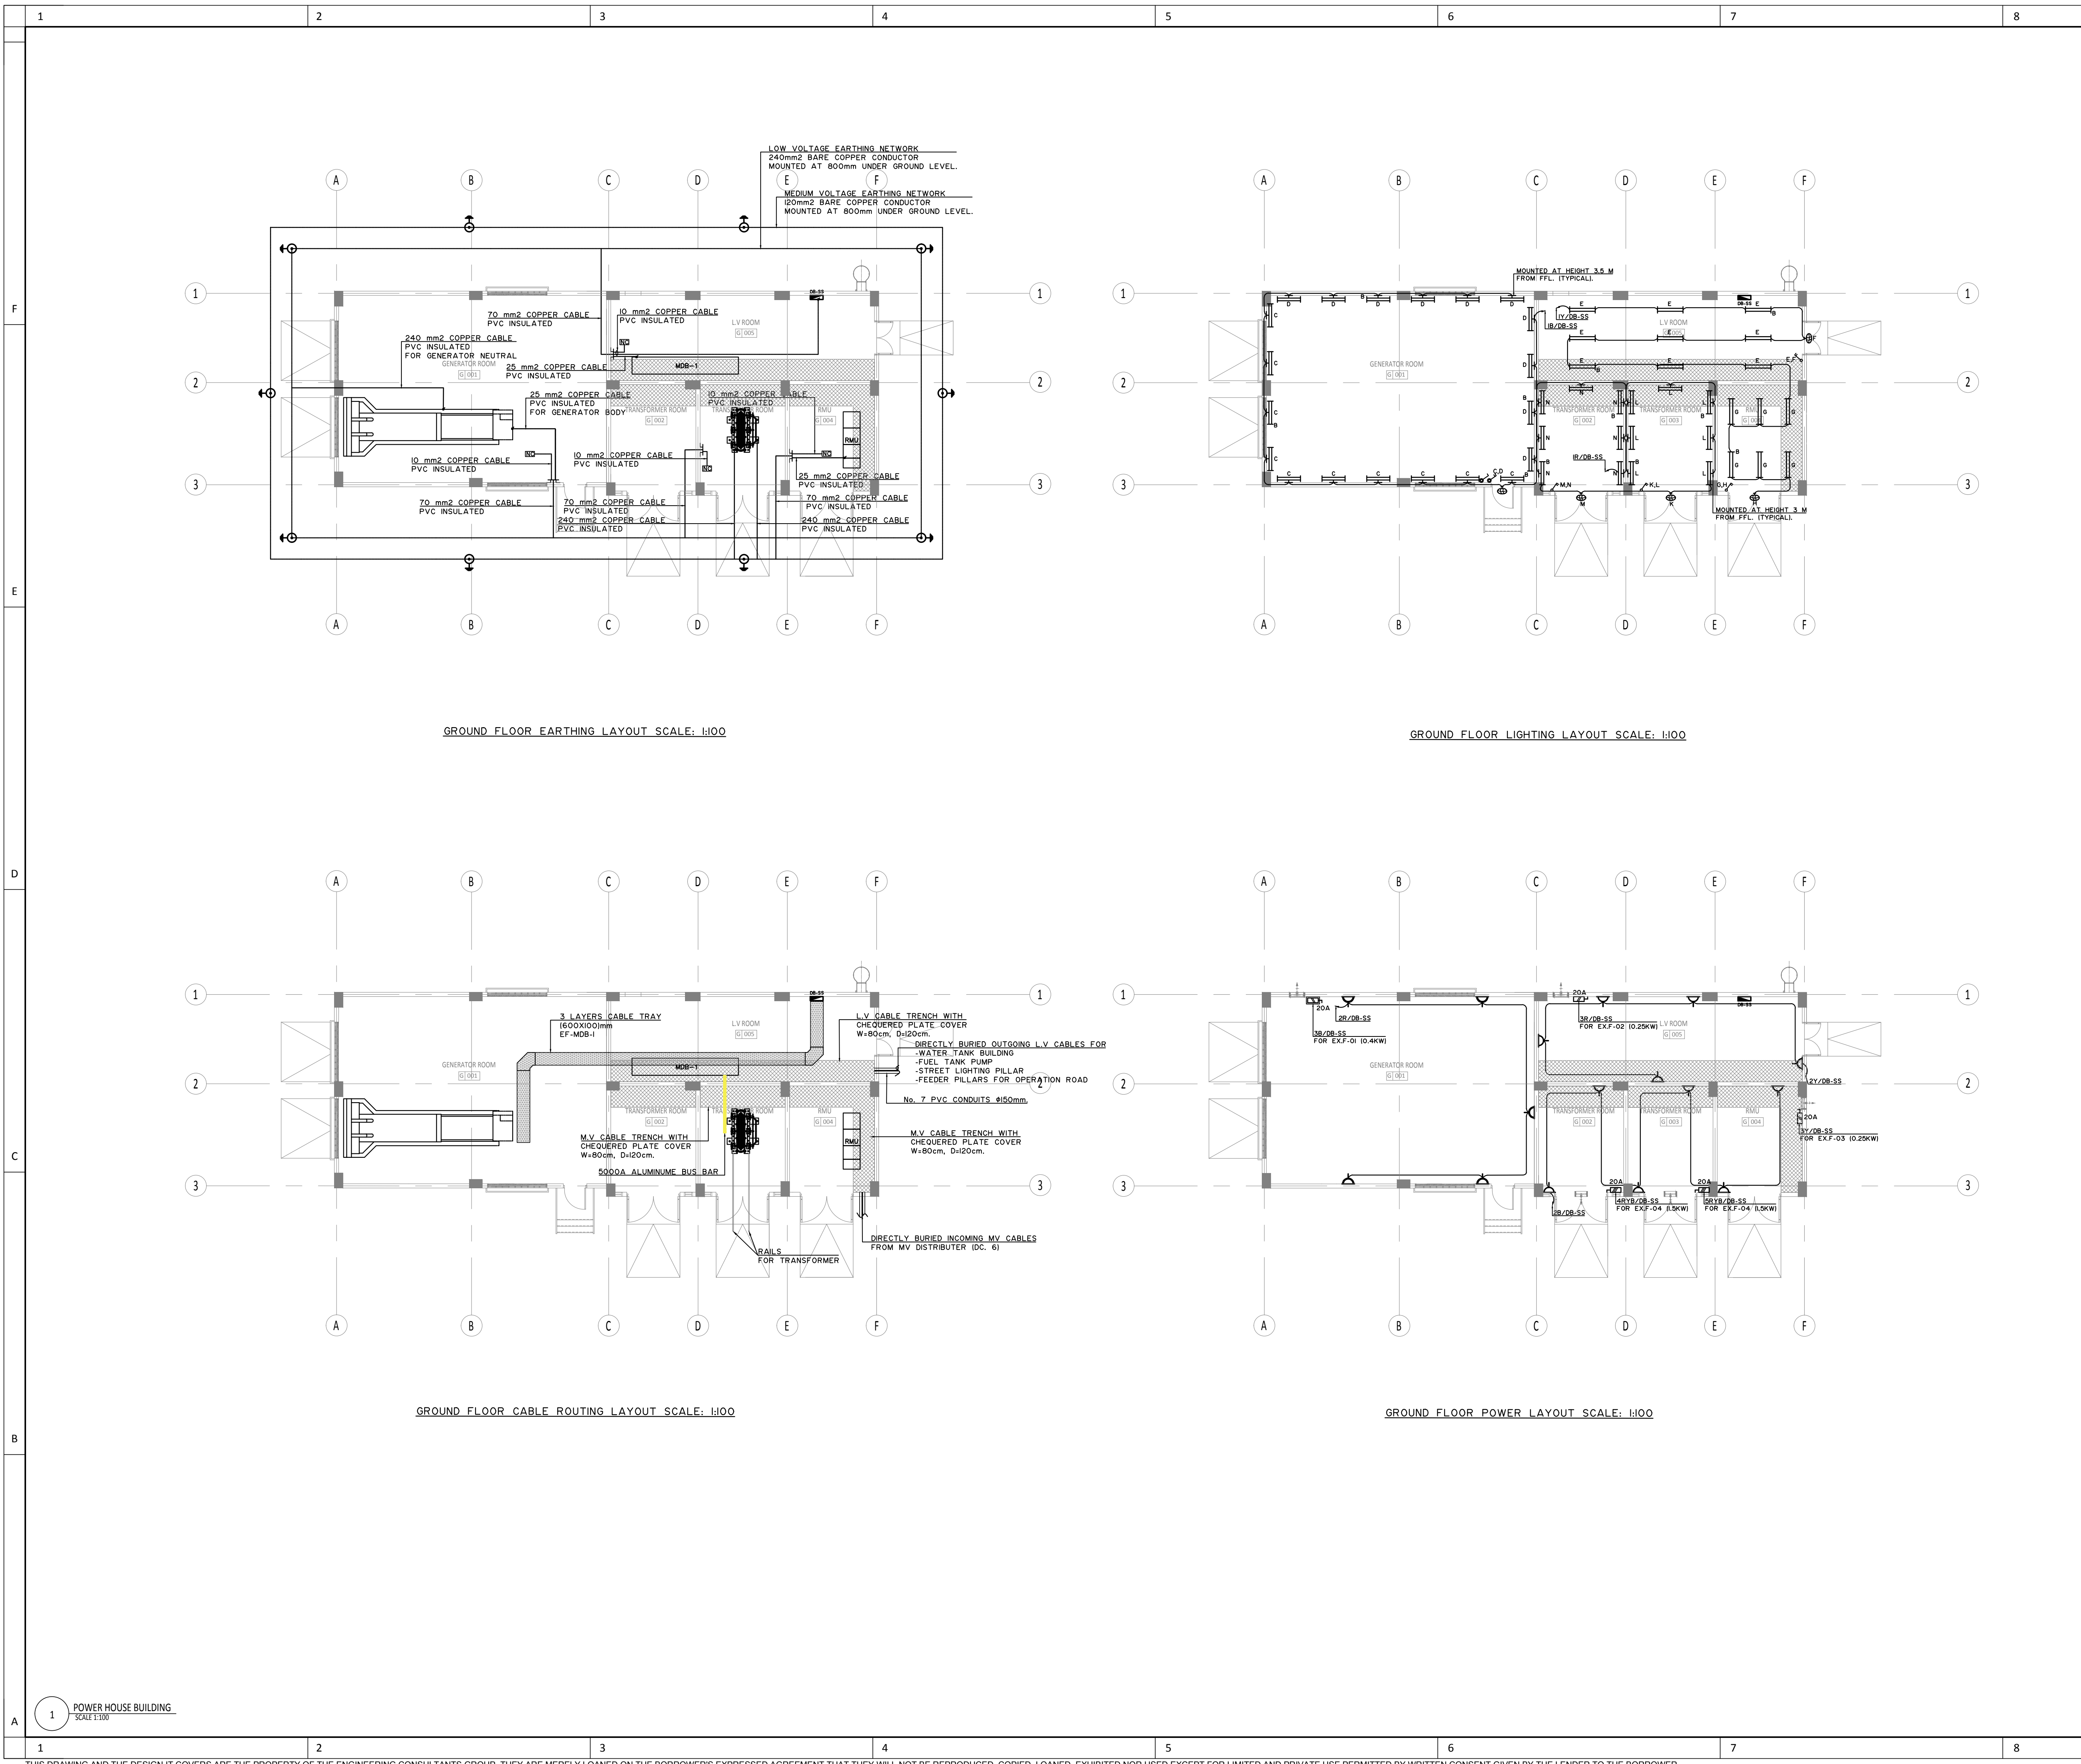

PROJECT

CITY GATE

CLIENT

BAWABET ELSHARQ NEW CAIRO FOR
REAL ESTATE INVESTMENTS S.A.E

PROJECT MANAGEMENT:

TURNER CONSTRUCTION INTERNATIONAL EGYPT

CONSULTANT

ECG

مراجعة الهندسة المعمارية

ENGINEERING CONSULTANTS GROUP s.a.

www.ecgsa.com

KEYPLAN

0

AUG-2024

CONSTRUCTION

Y.M.M.A.E

E.R.T.S

E.M.M.K.M

A.M.H.S.H

REV

DATE

ISSUED FOR

DRW

CHK

TL

PM

PROJECT TITLE

CITY GATE
NEW CAIRO

DISCIPLINE

ELECTRICAL

SHEET TYPE

GENERAL

SHEET TITLE

POWER HOUSE BUILDING LIGHTING,POWER,ROUTING & EARTHING LAYOUTS

SCALE

1:100

PROJECT NO.

2926

BLDG/SITE NO.

00

SHEET NO.

EX101

REV

0

SHEET SIZE : ISO A1 (594x841mm)

SCANNING SCALE

10mm

50mm

1 POWER HOUSE BUILDING
SCALE 1:100